


THIS DOCUMENT IS THE PROPERTY OF FEC HELIPORTS, A DIVISION OF FEDERAL EQUIPMENT COMPANY. CREATION AND REVISIONS CONTAINED ON THIS DOCUMENT SHALL NOT BE DISCLOSED TO OTHERS UNLESS THE MANUFACTURER, OR REPRESENTATIVE OF THE MANUFACTURER, HAS THE EXPRESS WRITTEN PERMISSION OF FEC HELIPORTS, A DIVISION OF FEDERAL EQUIPMENT COMPANY.


REVISION BLOCK

REVISION:	DATE:	REVISION NOTES:
*	1/11/11	

UPMC Passavant
9100 Babcock BLVD.
Pittsburgh, PA

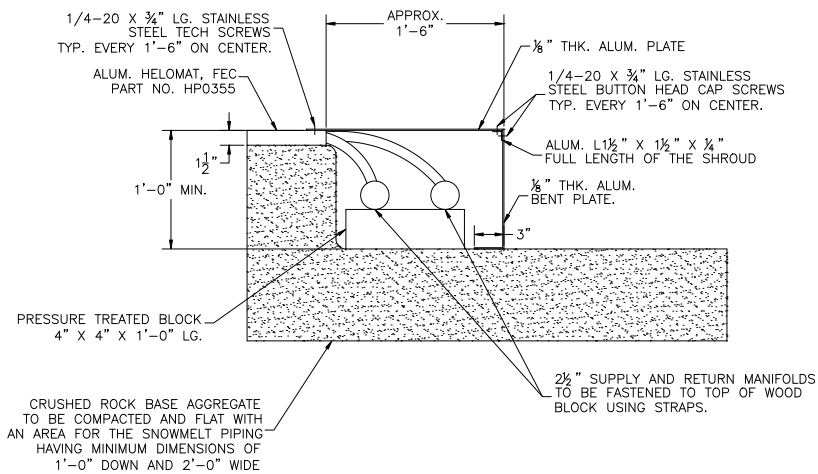

 M-2 CROSS SECTION OF MANIFOLD AND SHROUD
M-1



TYPICAL SUPPLY/RETURN MANIFOLD TO SUPPLY/RETURN PIPE CONNECTION.



A Division of
Federal Equipment Company,
3298 River rd.
Cincinnati, Ohio 45233
(513) 621-5260
(513) 621-0524 Fax
www.FECHeliports.com

DRAWN BY: JDB	CHECKED BY: JJS
JOB NO. 9371	
DATE: 10/09/07	
MECHANICAL DETAILS SCALE: 1" = 1'-0"	
DWG SIZE: D	REV LTR: -

M-2