




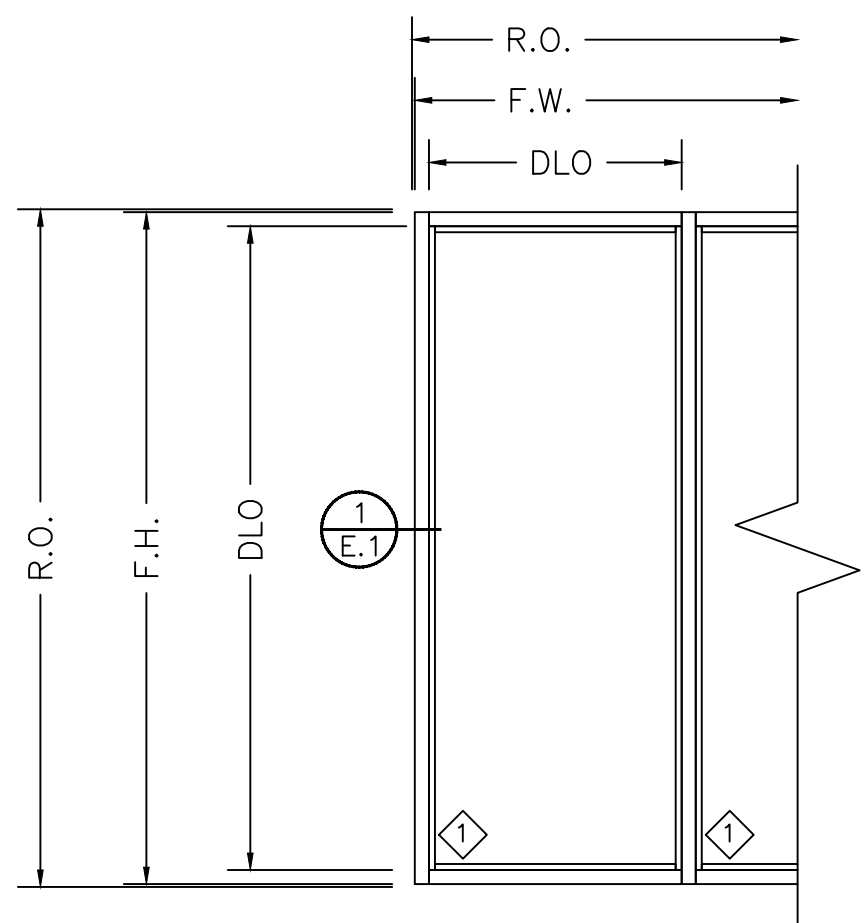


ELEVATION "A"
CURTAIN WALL

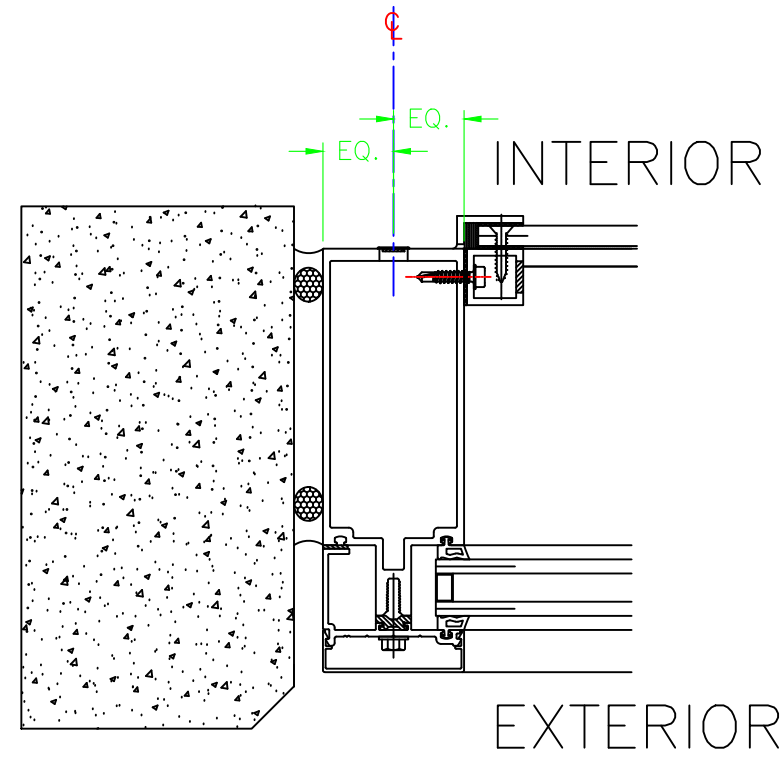

1 JAMB
ARCH. DETAIL REF.:
ARCH. SHEET REF.:

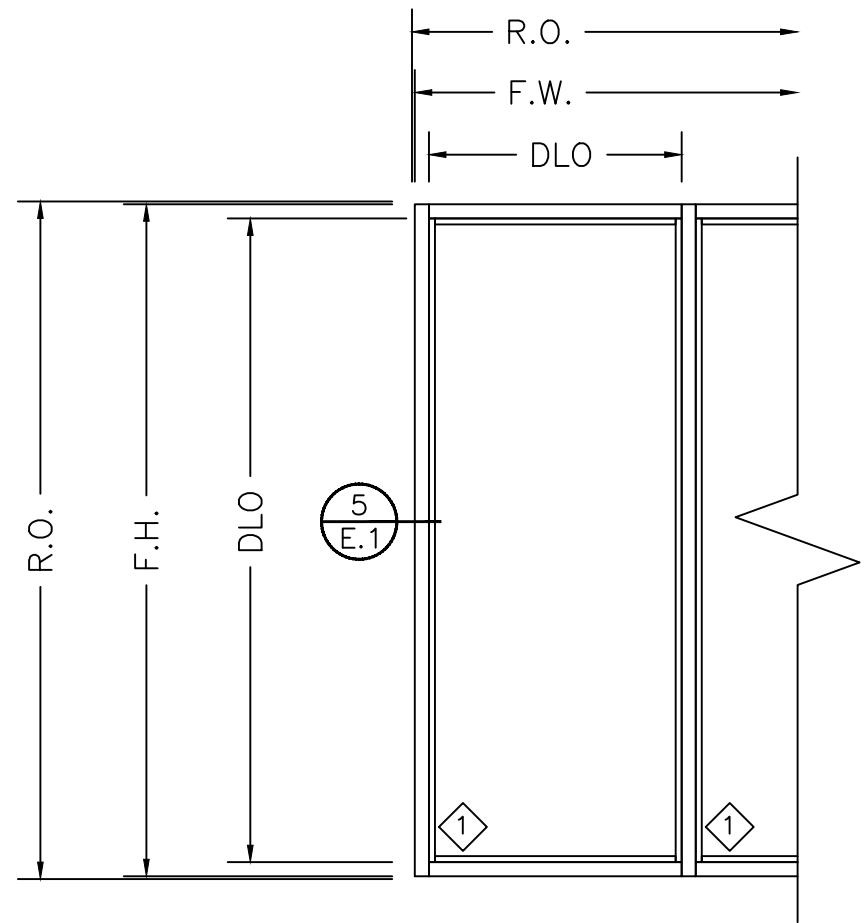


ELEVATION "A"
CURTAIN WALL

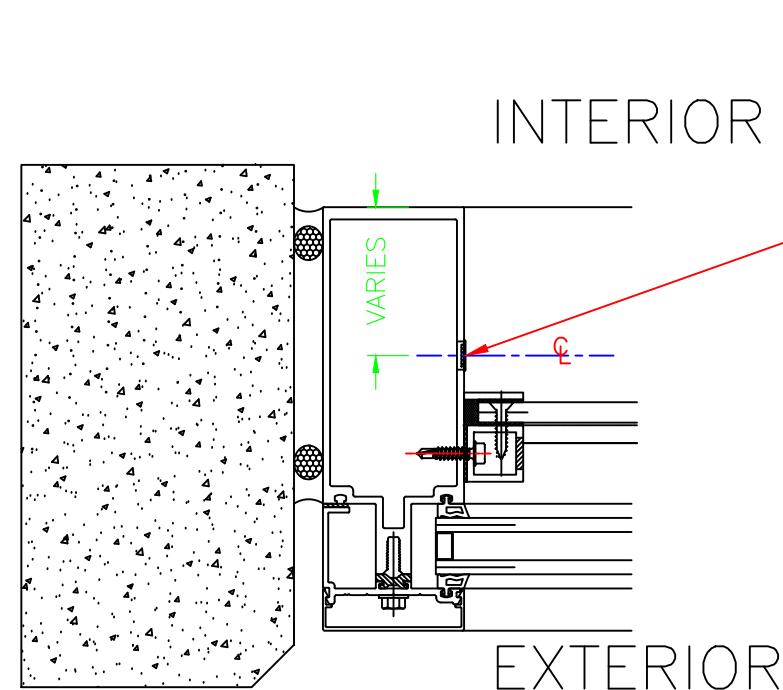


5 JAMB
ARCH. DETAIL REF.:
ARCH. SHEET REF.:


INSTALLATION NOTE:
WHEN DEFENSE SYSTEM IS
RECESSED WITHIN THE
CURTAIN WALL,
VENT HOLES TO BE DRILLED
INTO THE WINDOW WELL OF
VERTICAL MULLION.
**NOT THE FACE OF COVER.

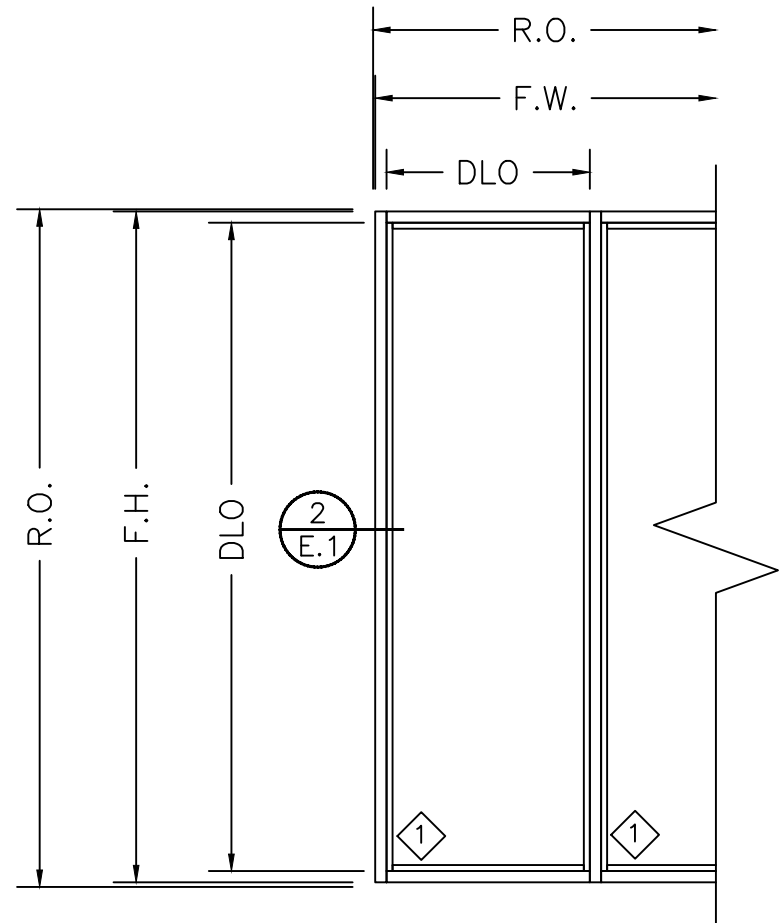


ELEVATION "B"
STOREFRONT
FRONT SET

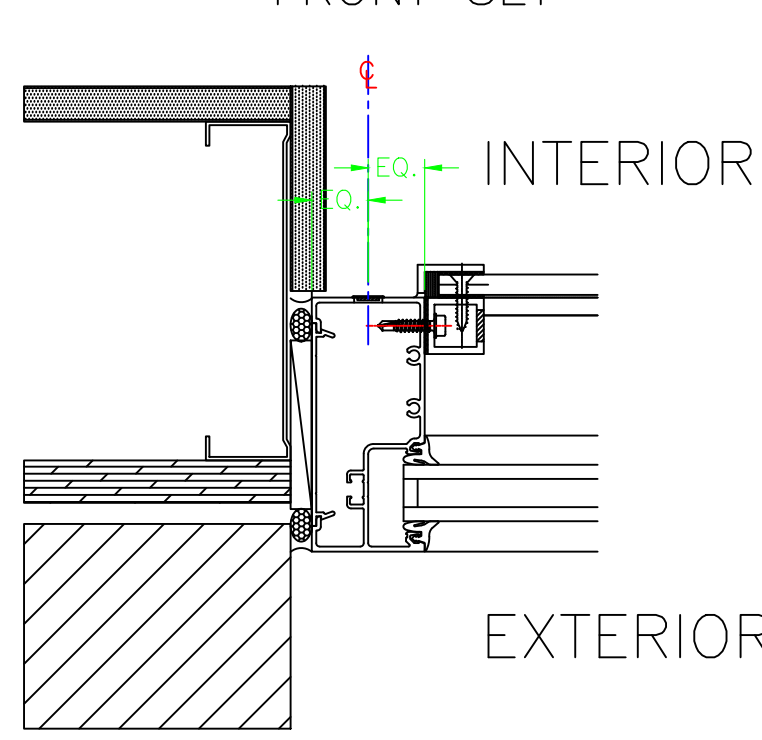


2 JAMB
ARCH. DETAIL REF.:
ARCH. SHEET REF.:

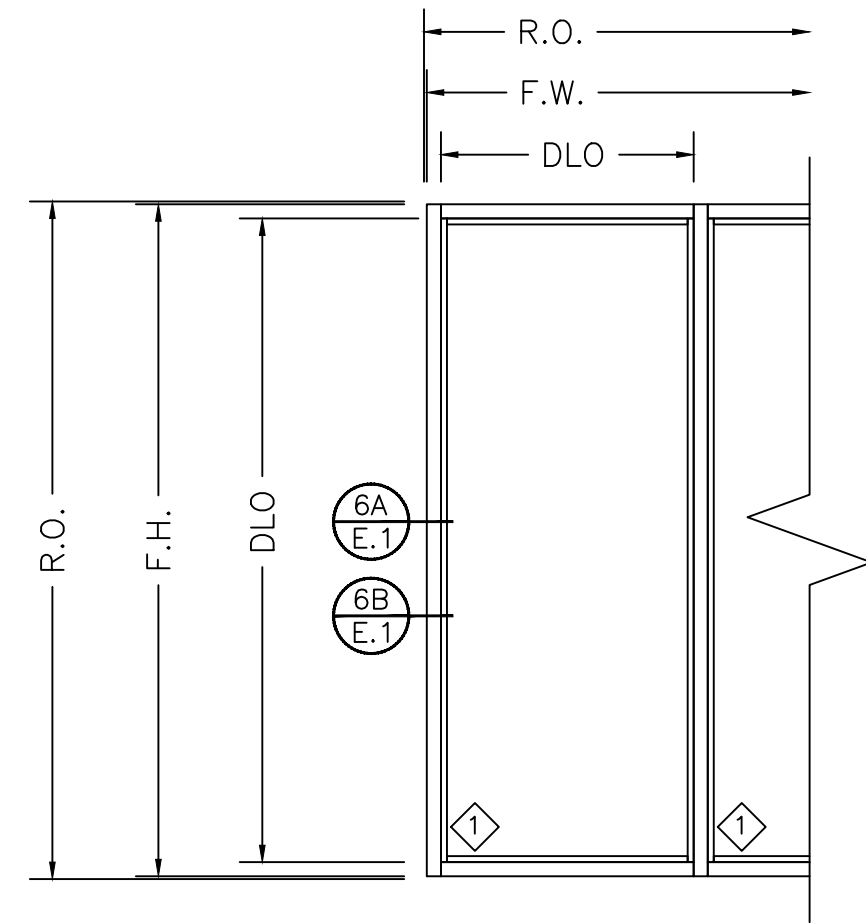


ELEVATION "E"
EXTERIOR HOLLOW METAL

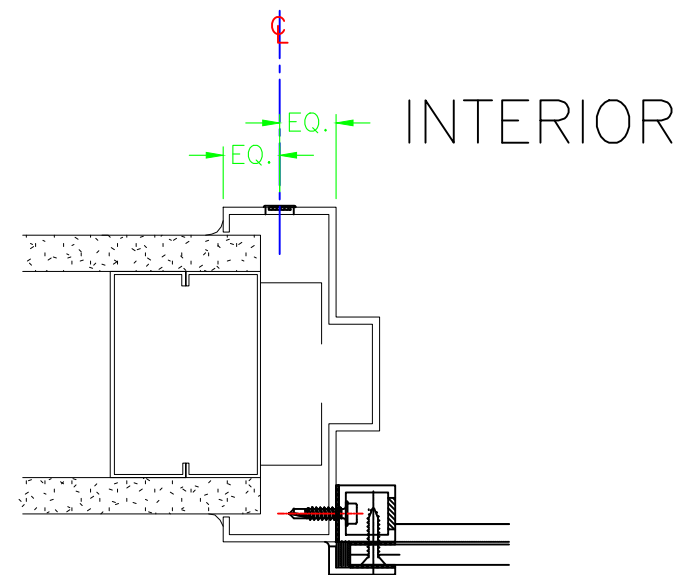


6A JAMB
ARCH. DETAIL REF.:
ARCH. SHEET REF.:

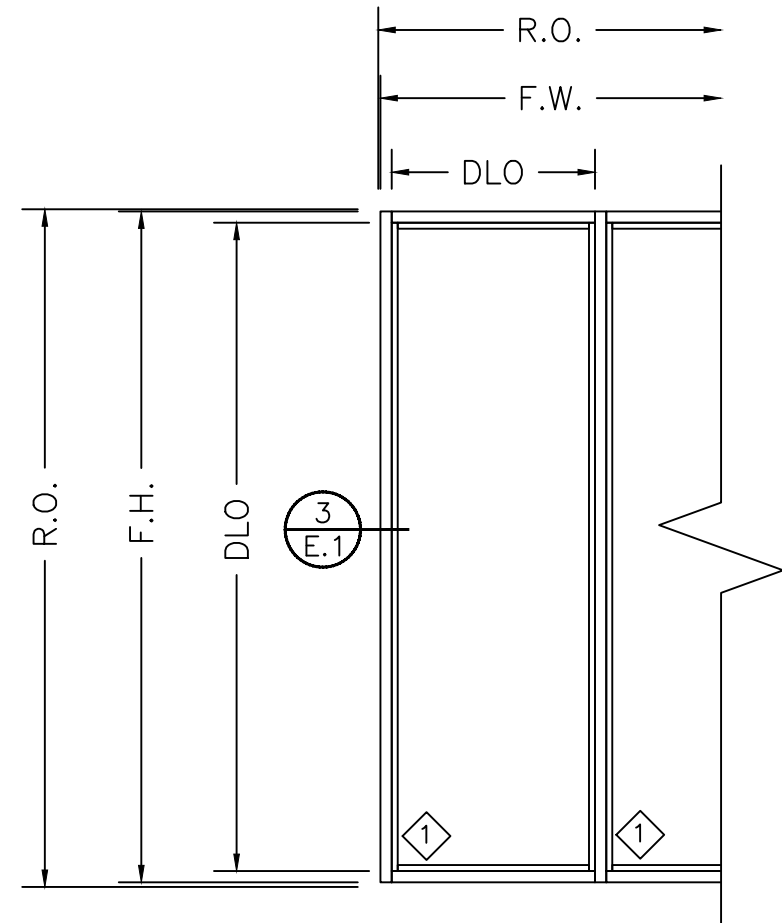


ELEVATION "C"
STOREFRONT
CENTER SET

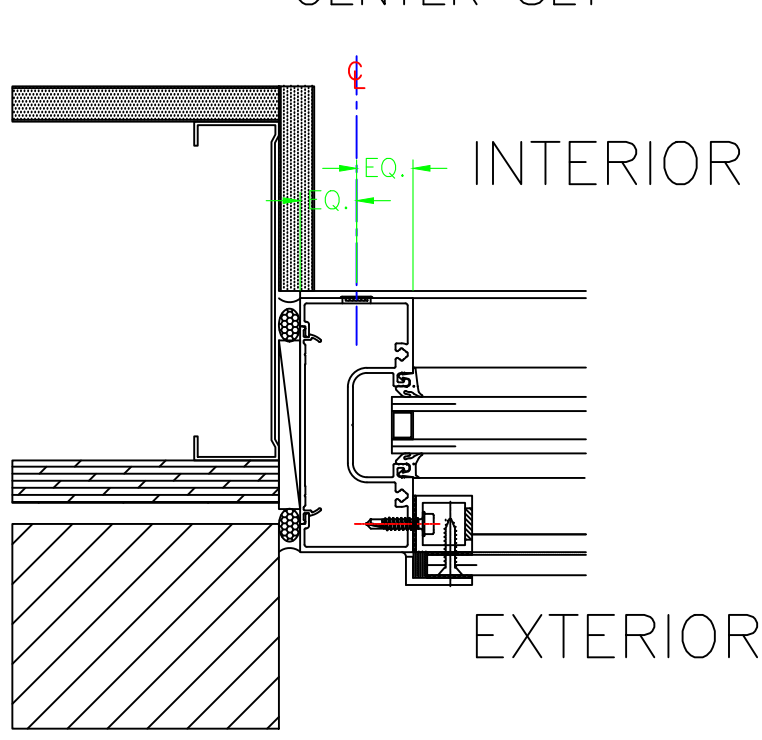


3 JAMB
ARCH. DETAIL REF.:
ARCH. SHEET REF.:

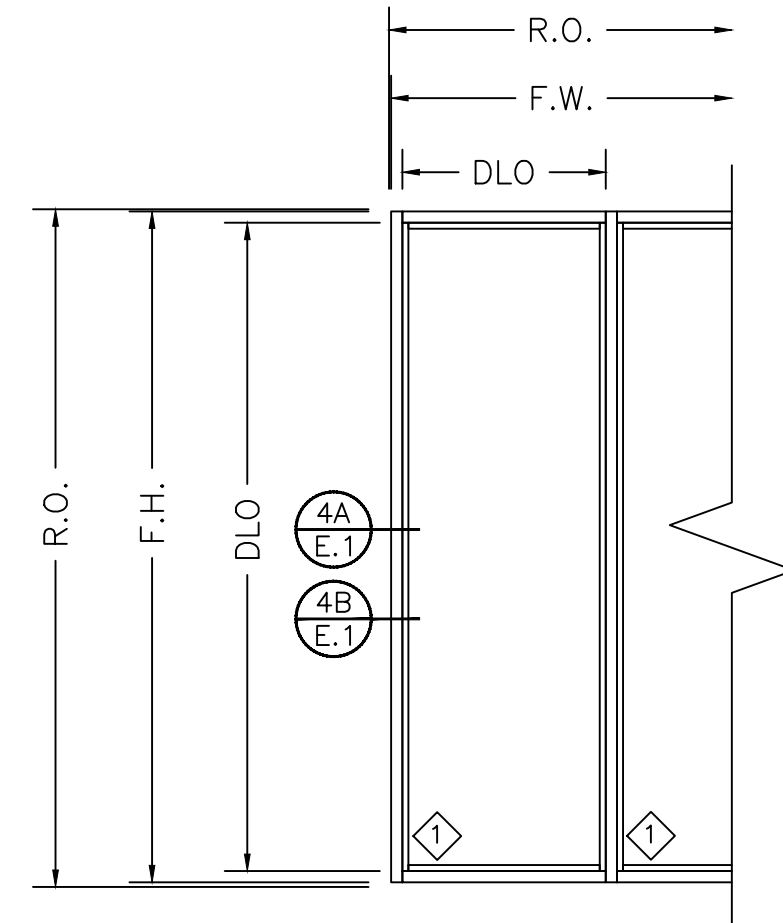

ELEVATION "D"
STOREFRONT
BACK SET

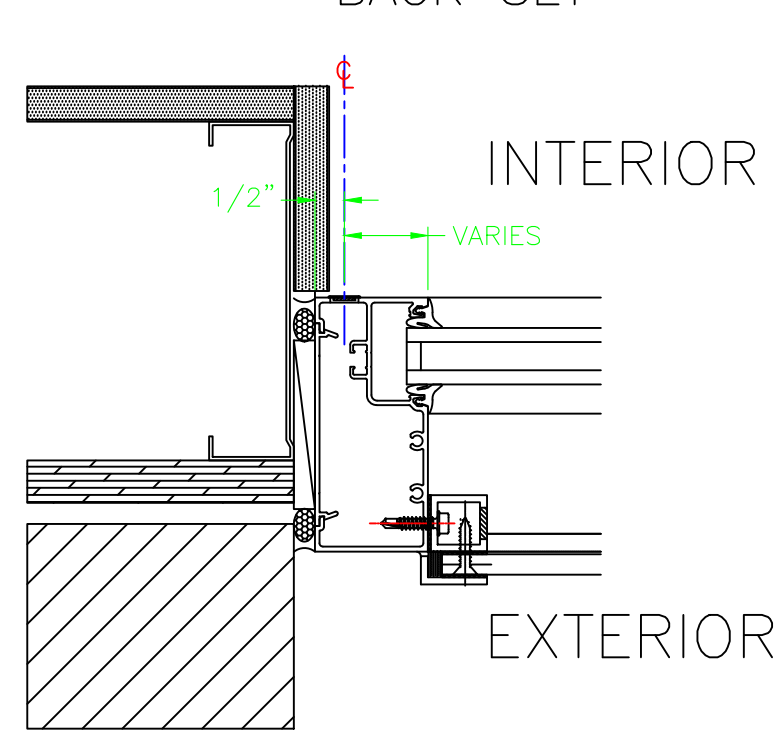

4A JAMB
ARCH. DETAIL REF.:
ARCH. SHEET REF.:

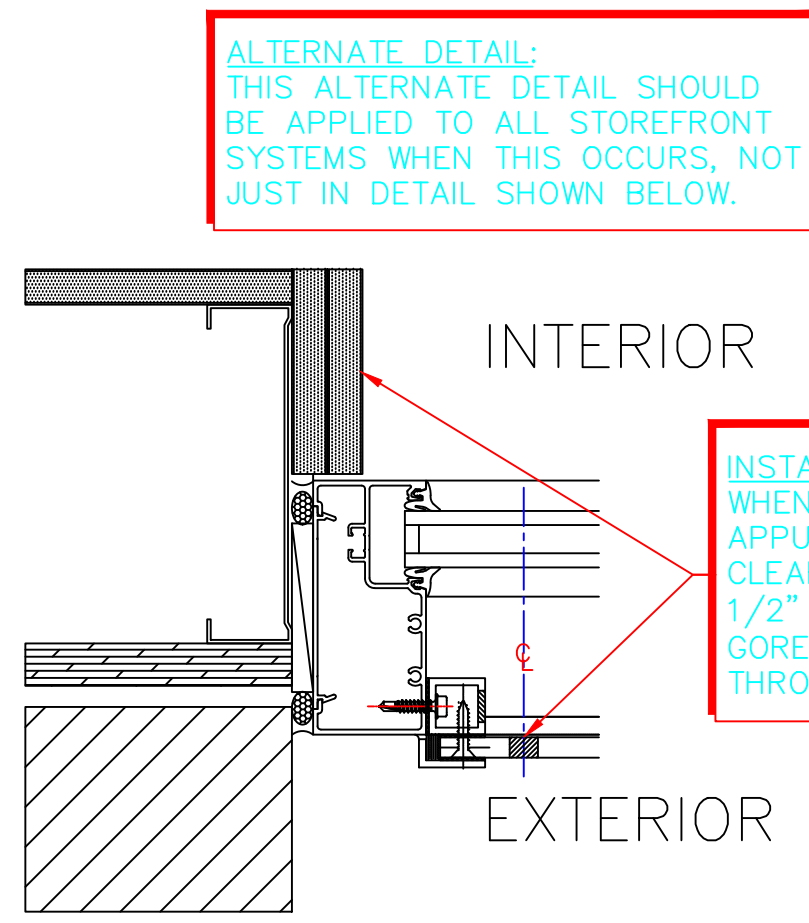


4B ALTERNATE JAMB GORE VENT
ARCH. DETAIL REF.:
ARCH. SHEET REF.:

NOTES:
1) ALL DETAILS SHOWN IN DL PRO APPLICATIONS;
HOWEVER THESE SAME CONDITIONS EXIST ON DL
STANDARD SYSTEMS.

2) VENTILATION IS NOT USED ON INTERIOR
MOUNTED SYSTEM(S) OF ANY KIND, UNLESS
THERE ARE SOME SORT OF SPECIAL CONDITIONS.
THEN NEW DETAILS WOULD BE CREATED
APPLICABLE TO THE SPECIFIC PROJECT
CONDITION.

ALTERNATE DETAIL:
THIS ALTERNATE DETAIL SHOULD
BE APPLIED TO ALL STOREFRONT
SYSTEMS WHEN THIS OCCURS, NOT
JUST IN DETAIL SHOWN BELOW.

INSTALLATION NOTE:
WHEN DRYWALL OR OTHER
APPURTENANCES IMPEDE THE
CLEARANCE REQUIRED TO DRILL
1/2" HOLE, CONVERT TO A
GORE VENT SYSTEM APPLICATION
THROUGH THE SHIELD.

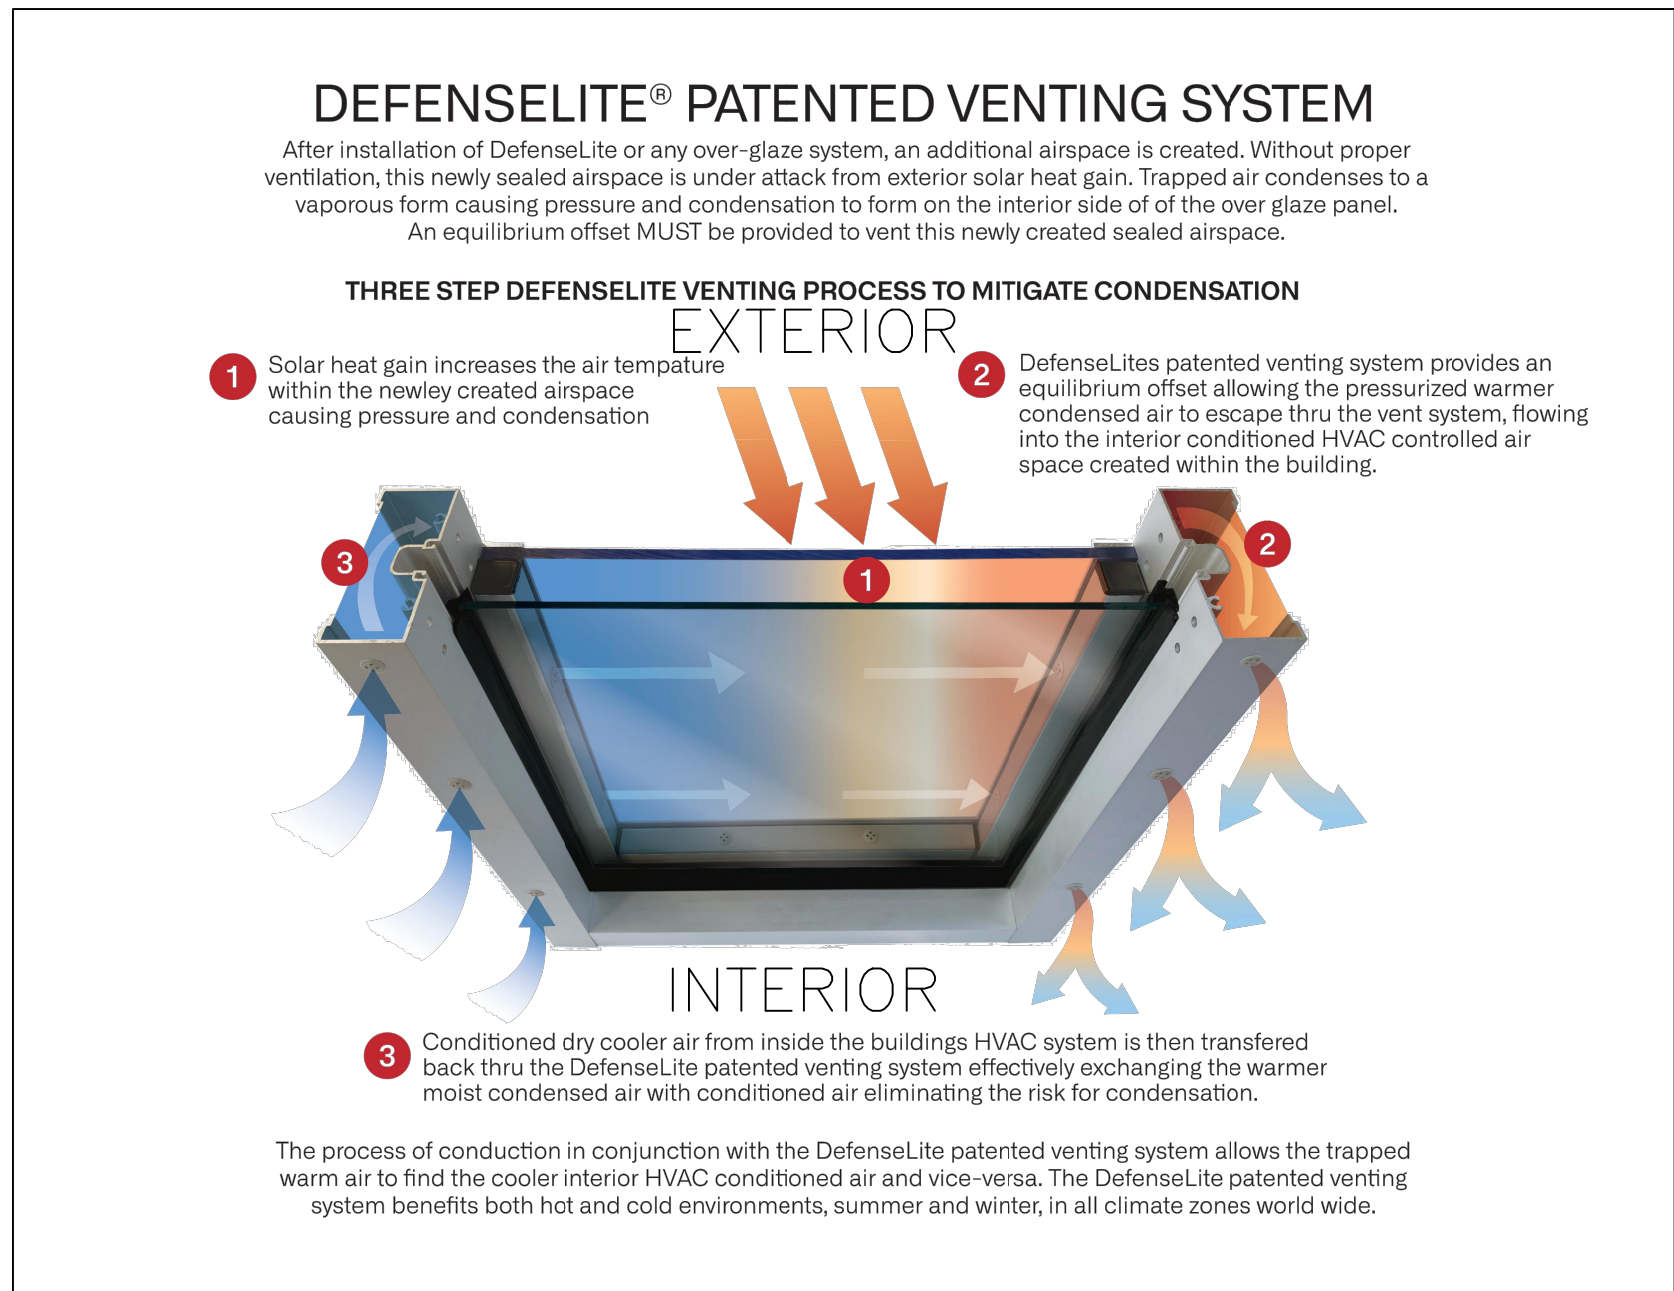

MOORE VENTING:
THE USE OF INTERIOR AIR SPACE AND FILTERED VENTILATION
MATERIALS TO CIRCULATE CONDITIONED AIR WITHIN THE CAVITY. THE
SYSTEM VENTILATES TO THE INTERIOR OF THE PROTECTED BUILDING.

GORE VENTING:
THE USE OF PREFABRICATED VENTING TECHNOLOGY THAT IS
APPLIED TO THE SHIELD FACE OR FRAME IN A PREDETERMINED
LAYOUT, BASED ON OVERALL PANEL SIZE. THIS SYSTEM VENTILATES
TO THE EXTERIOR OF THE PROTECTED BUILDING.

IMPACT SECURITY 600 KIRK ROAD #100 MARIETTA, GEORGIA 30068 678-801-9572 678-547-3138 FAX			
CO BY			
ISSUE DATE			
REVISION			
NO.			
ARCHITECT NAME AND LOCATION:			
CUSTOMER NAME AND LOCATION:			
PROJECT NAME AND LOCATION: DEFENSE LITE - STANDARD VENTILATION DETAILS MOORE VENTING			
DESCRIPTION: ELEVATION SHEET			
SCALE: 3/8":1'-0"	ISSUE DATE: 12-02-24		
DRAWN BY: CDD	SHEET NO.: E.1		
JOB NUMBER:			